



ST0.0

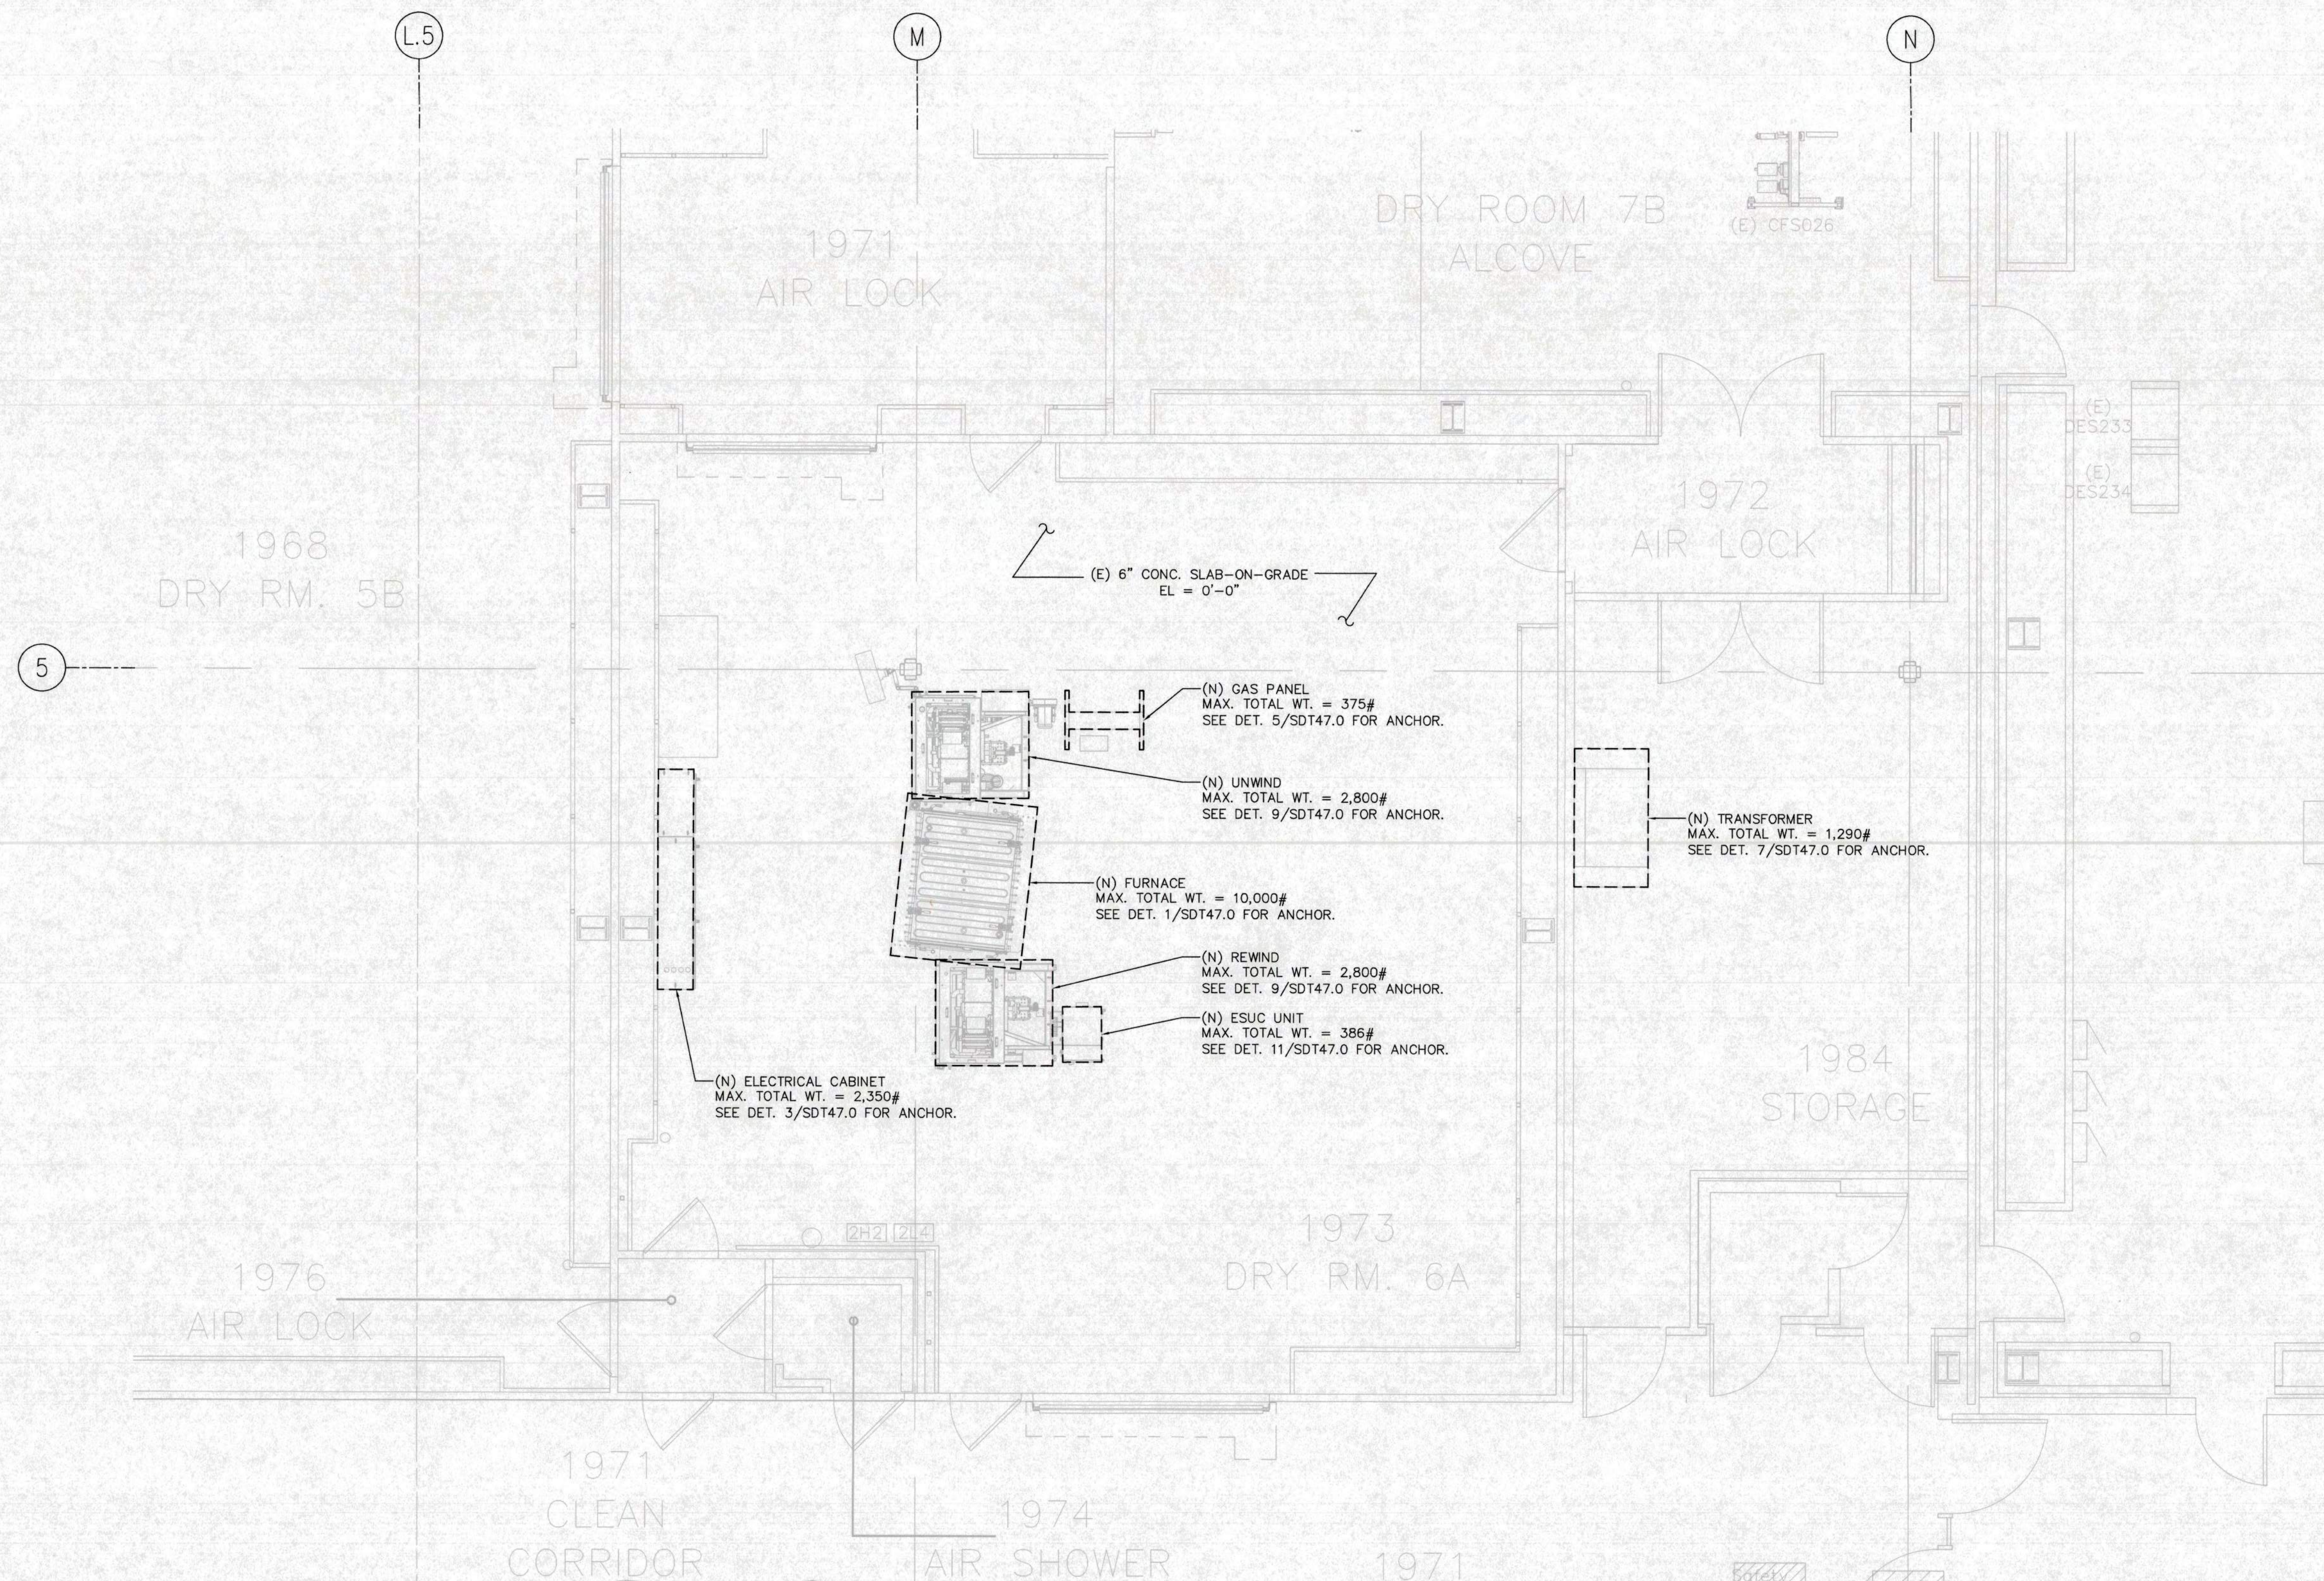

PARTIAL FLOOR PLAN AND EQUIPMENT LAYOUT
SCALE: 1/4"=1'-0"

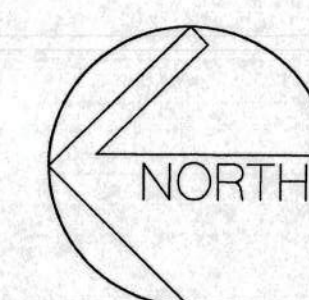

EQUIPMENT INSTALLATION NOTES:

1. ALL STEEL BRACKETS AND MISCELLANEOUS IRON USED INSIDE CLEANROOM SHALL BE POWDER-COATED OR STAINLESS STEEL.
2. DIMENSIONS SHOWN FOR EQUIPMENT MAY NOT MATCH THE OVERALL ARCHITECTURAL DIMENSIONS OR SPACE OCCUPIED BY EQUIPMENT. THEY ARE ONLY INTENDED FOR STRUCTURAL PURPOSE & ANCHORAGE DESIGN & MAINLY INDICATE (OR APPROXIMATE) BASE FOOTPRINT OF EQUIPMENT.
3. CONTRACTOR SHALL VERIFY ALL DIMENSIONS IN FIELD AND NOTIFY SEOR IF ANY DISCREPANCIES WERE DISCOVERED.
4. WEIGHT OF EQUIPMENT SHOWN ARE CONSIDERED MAXIMUM OPERATIONAL WEIGHT AND REPRESENT AVAILABLE KNOWLEDGE AT THE TIME OF DESIGN. CONTRACTOR SHALL NOTIFY SEOR & OWNER IF THEY SUSPECT A DISCREPANCY EXISTS. THIS EFFORT IS INTENDED AS A VERIFICATION TO ENSURE INSTALLED TOOL CORRELATES WITH THE DESIGN ASSUMPTIONS.
5. CONTRACTOR SHALL POSITIVELY SECURE ALL EQUIPMENTS TO THE STRUCTURE.
6. WHEN ANCHORAGE DETAILS SHOW POSITIVE FASTENING TO BODY OF THE EQUIPMENT (SCREWS, TAPPED BOLT, THRU BOLTS...) CONTRACTOR SHALL COORDINATE WITH OWNER TO ENSURE SUCH CONNECTIONS DO NOT ADVERSELY AFFECT THE EQUIPMENT AT THE LOCATION THEY ARE SHOWN.

LEGEND:

[] INDICATES (N) EQUIPMENT

CITY OF SAN JOSE
BUILDING DIVISION
DATE: _____

BLDG. 2 PHASE 2.53 - INDUSTRIAL TOOL
INSTALLATIONS

GENERAL NOTES & STRUCTURAL SPECIFICATIONS

Scale: AS NOTED

Project No: 26023

DWG. NO.

ST47.0

APPLIED ENGINEERING
CONSULTING STRUCTURAL ENGINEERS
901 MONTAGUE BLVD., SUITE 207
SAN JOSE, CA 95128
TEL: (408) 283-9800 FAX: (408) 283-9815
EMAIL: info@appliedee.com

PROFESSIONAL ENGINEER
REGISTERED
C 44468
S 3593
CIVIL & STRUCTURAL
STATE OF CALIF.

Rev	Date	Revision
0	06-03-26	ISSUED FOR PERMIT


Pacific Crest
ENGINEERING INC.

444 Airport Blvd., Suite 106
Watsonville, CA 95076
Ph: (831) 763-6191
Fax: (831) 722-9158

QuantumScape
BATTERY, Inc.


1710 AUTOMATION PARKWAY
SAN JOSE
CALIFORNIA 95131

* CONTRACTOR TO VERIFY DIMENSIONS WITH MANUFACTURER

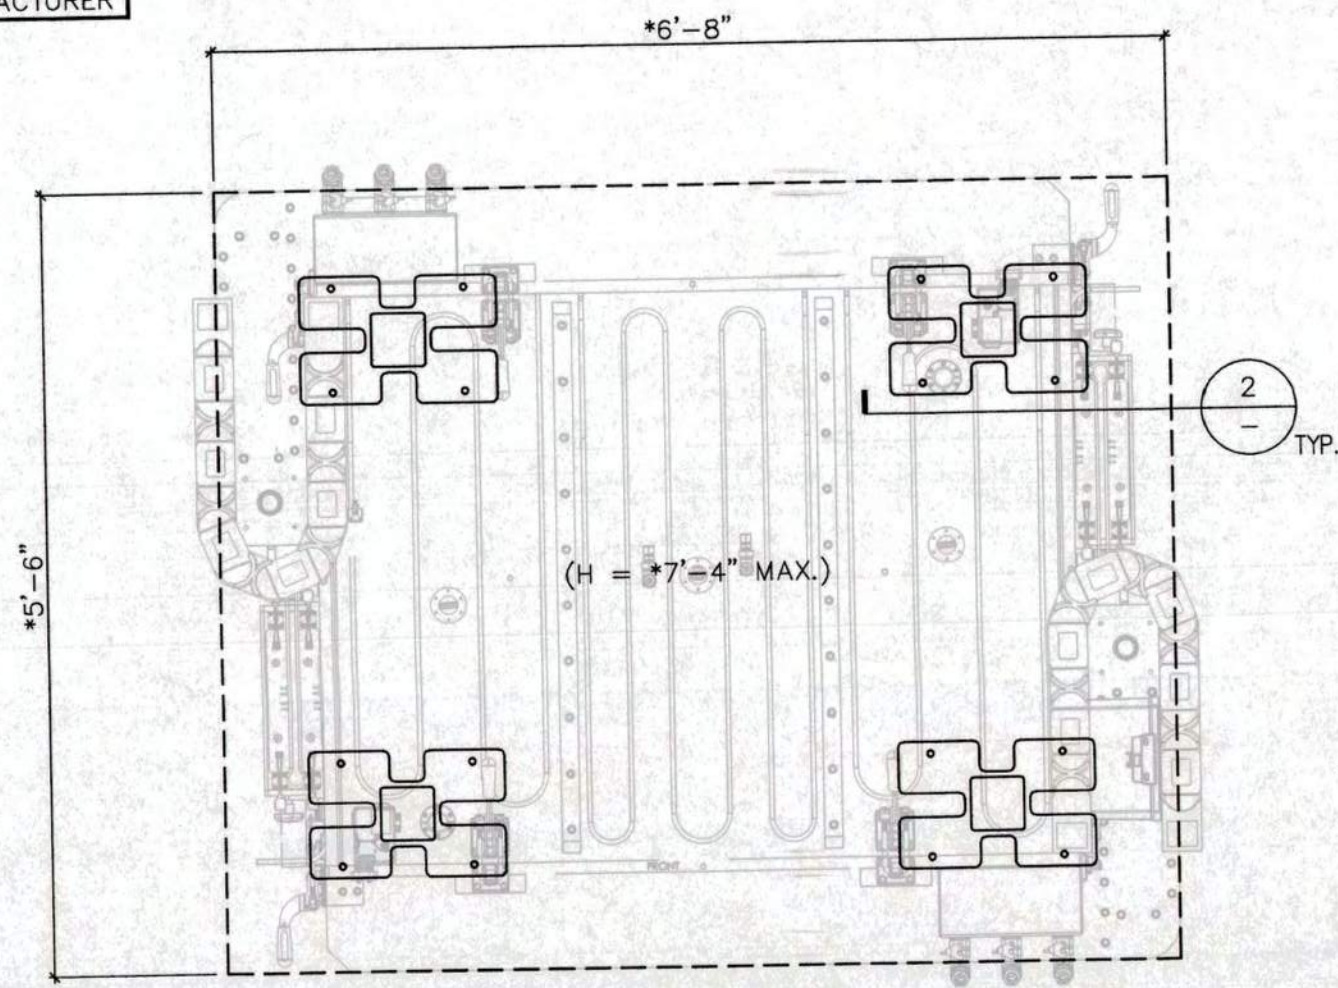


1 ANCHOR LAYOUT
FURNACE

NOTE: CONTRACTOR SHALL VERIFY ALL DIMENSIONS IN FIELD. NO DEVIATION FROM DETAIL IS PERMITTED W/O WRITTEN APPROVAL FROM SEOR.

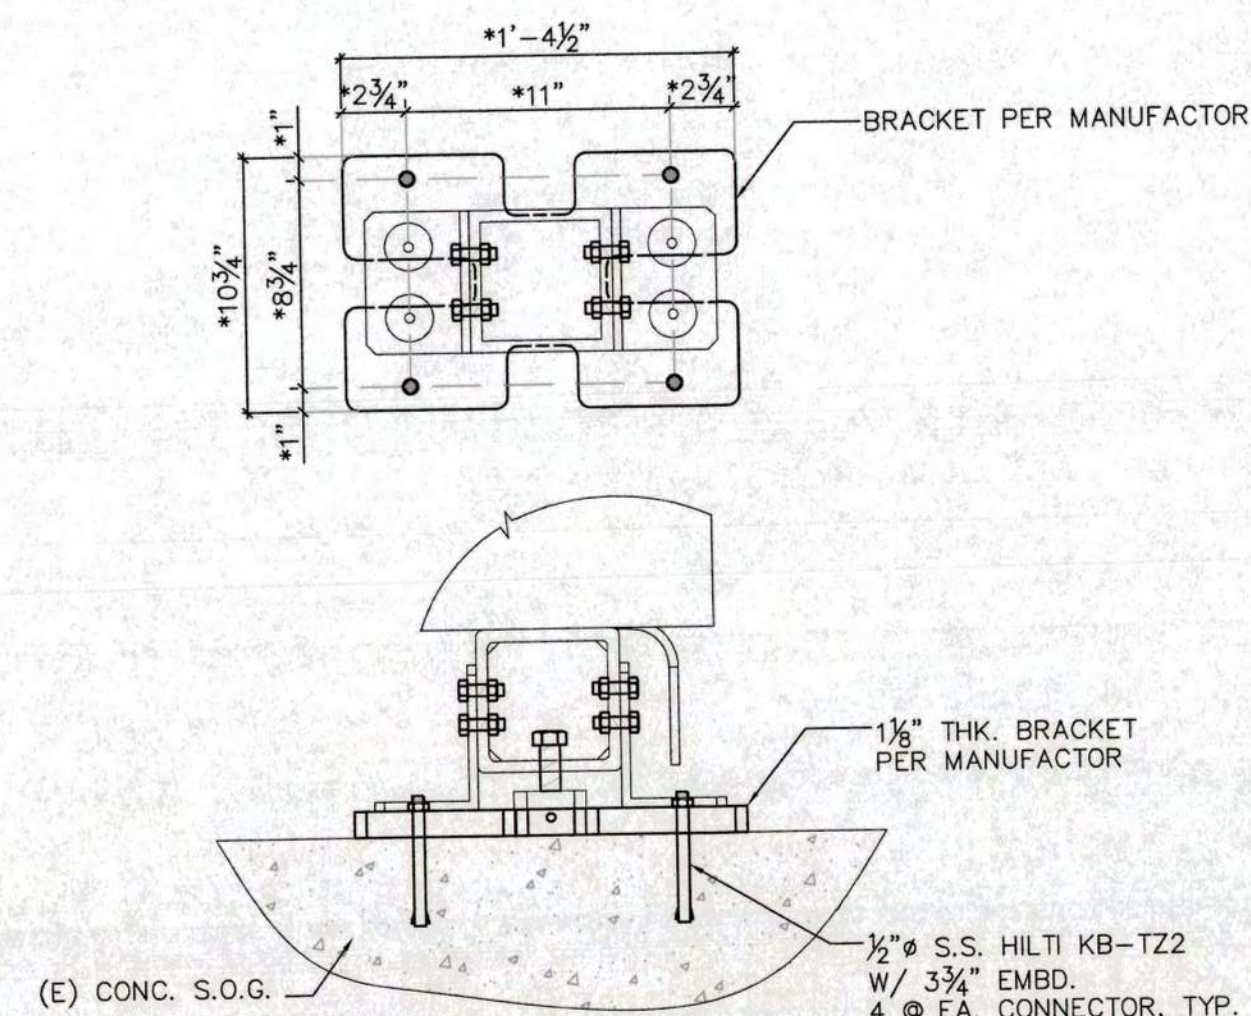


2 ANCHOR DETAILS
FURNACE

* CONTRACTOR TO VERIFY DIMENSIONS WITH MANUFACTURER

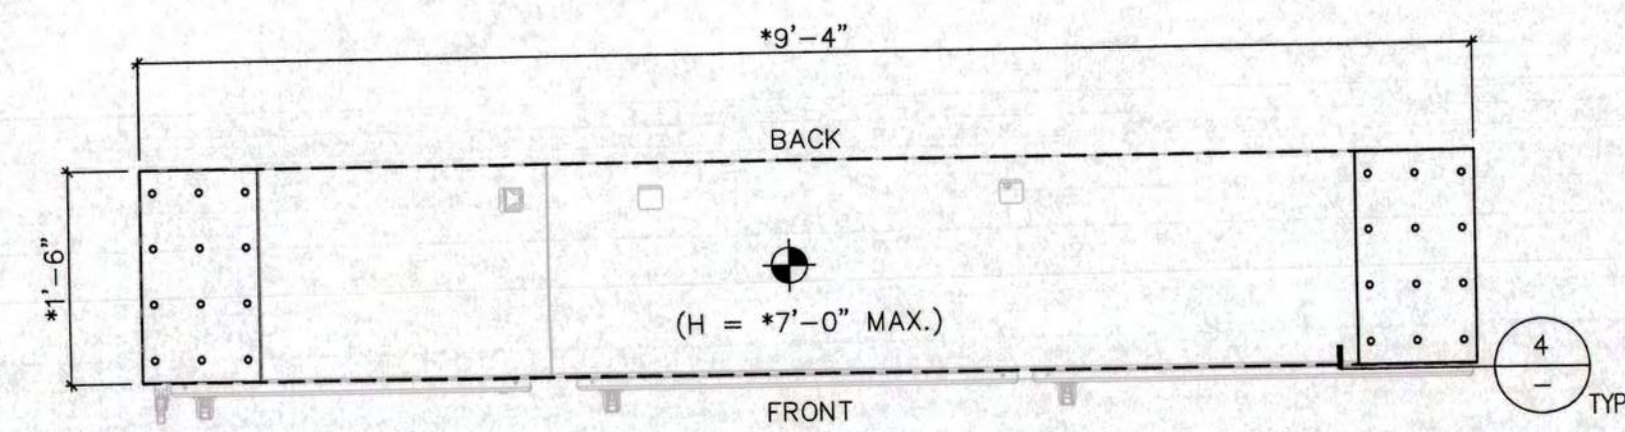


3 ANCHOR LAYOUT
ELECTRICAL CABINET

NOTE: CONTRACTOR SHALL VERIFY ALL DIMENSIONS IN FIELD. NO DEVIATION FROM DETAIL IS PERMITTED W/O WRITTEN APPROVAL FROM SEOR.

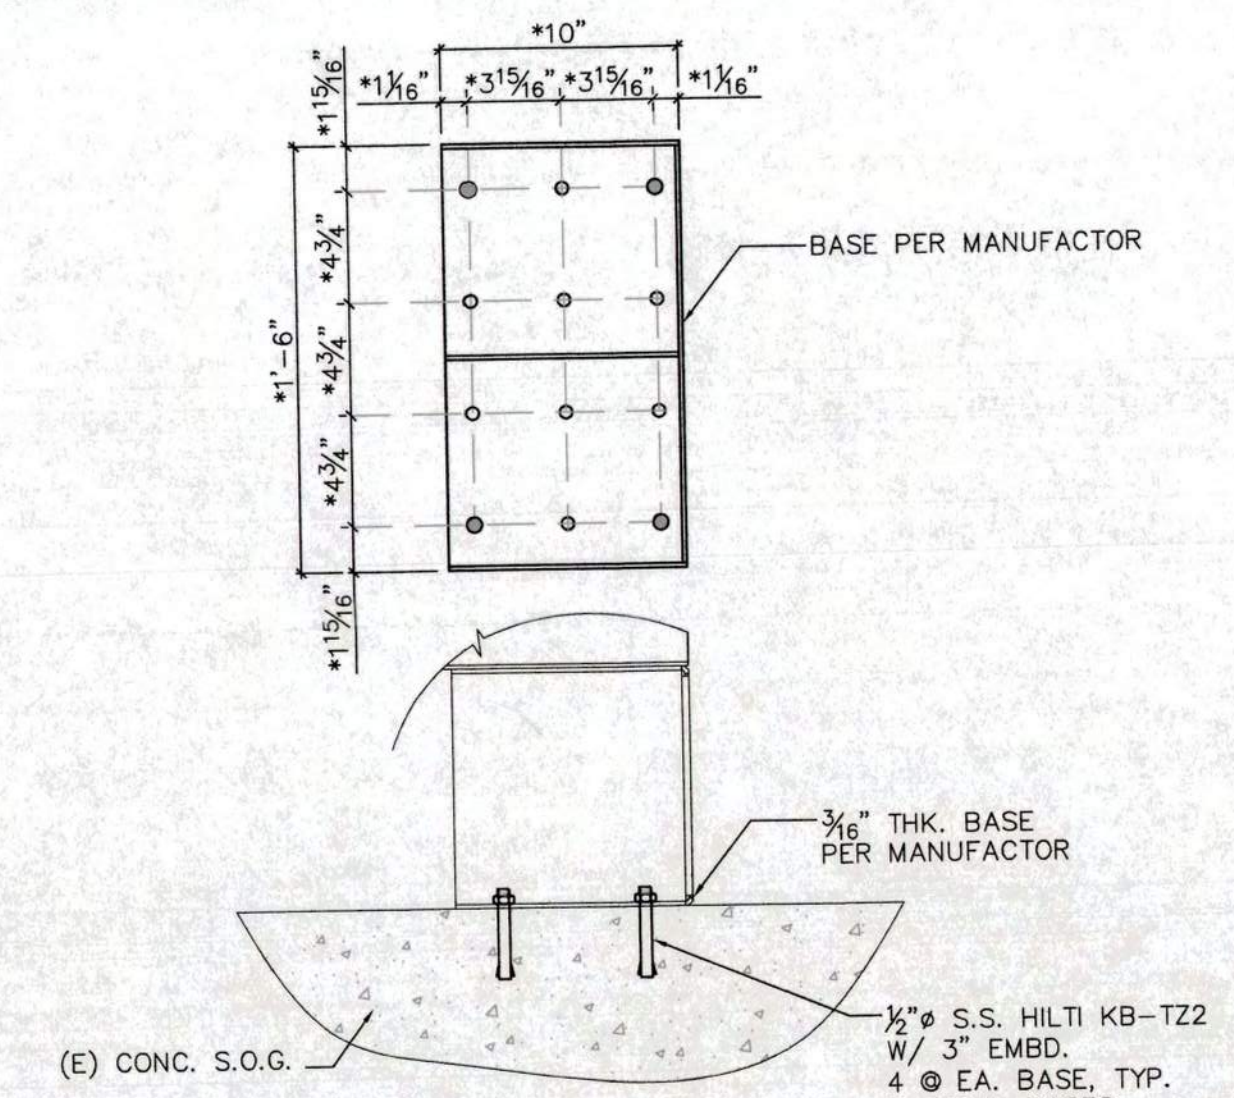


4 ANCHOR DETAILS
ELECTRICAL CABINET

* CONTRACTOR TO VERIFY DIMENSIONS WITH MANUFACTURER

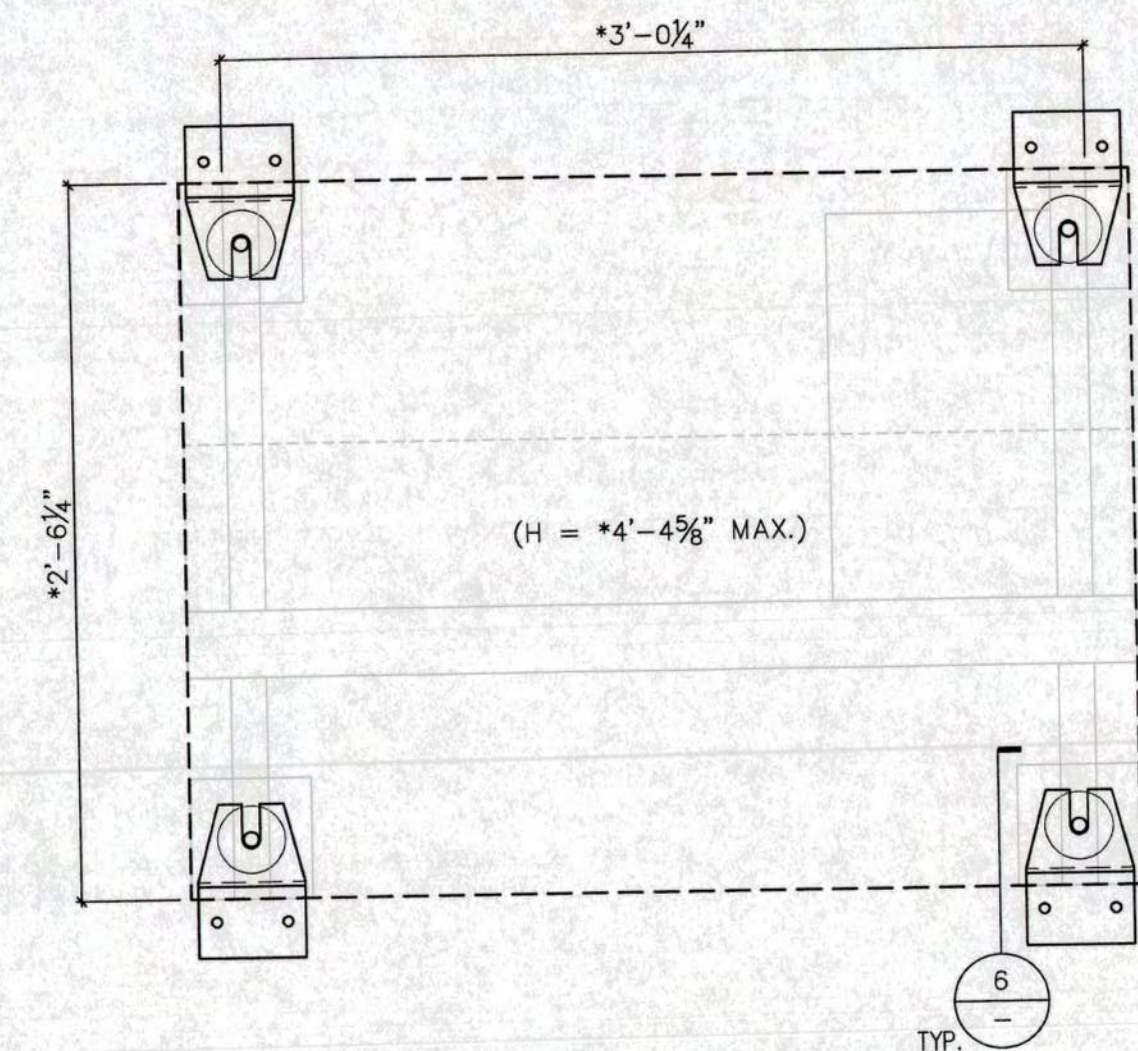


5 ANCHOR LAYOUT
GAS PANEL

NOTE: CONTRACTOR SHALL VERIFY ALL DIMENSIONS IN FIELD. NO DEVIATION FROM DETAIL IS PERMITTED W/O WRITTEN APPROVAL FROM SEOR.

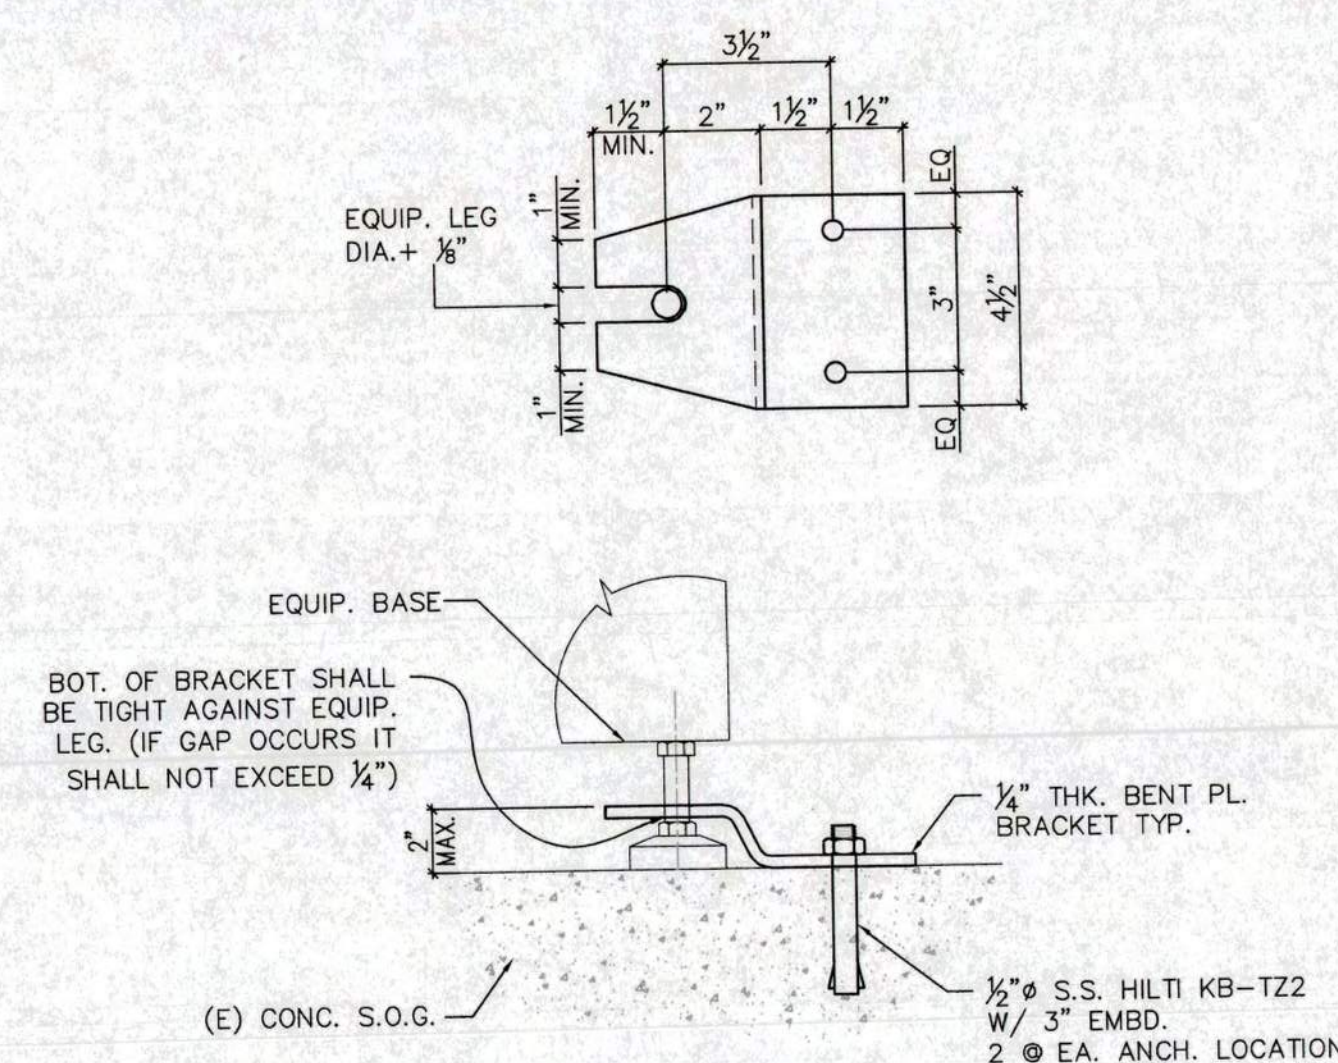


6 ANCHOR DETAILS
GAS PANEL

* CONTRACTOR TO VERIFY DIMENSIONS WITH MANUFACTURER

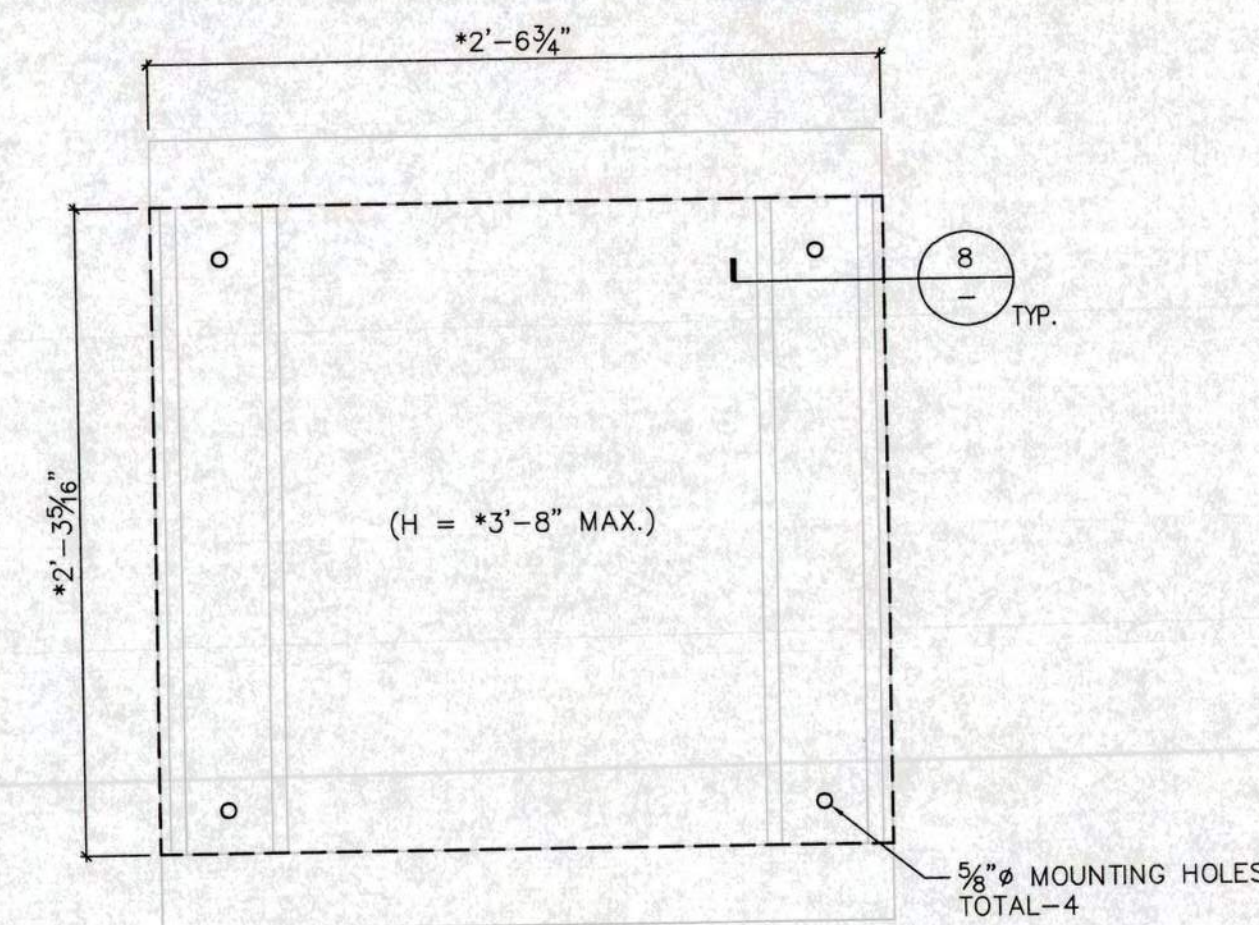


7 ANCHOR LAYOUT
TRANSFORMER

NOTE: CONTRACTOR SHALL VERIFY ALL DIMENSIONS IN FIELD. NO DEVIATION FROM DETAIL IS PERMITTED W/O WRITTEN APPROVAL FROM SEOR.

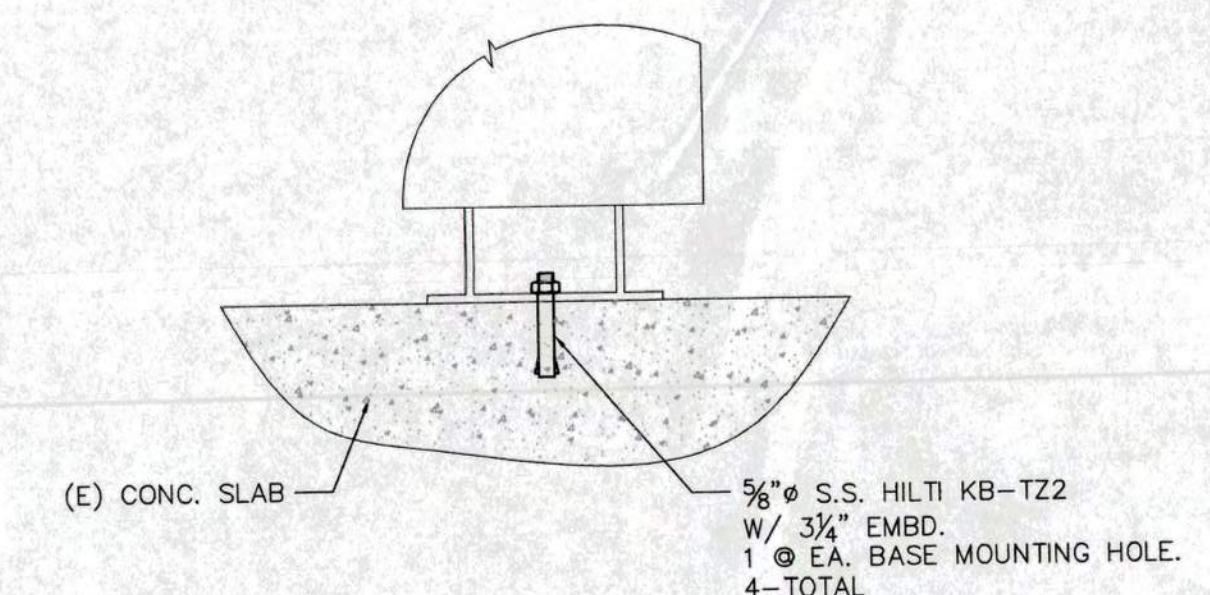


8 ANCHOR DETAIL
TRANSFORMER

* CONTRACTOR TO VERIFY DIMENSIONS WITH MANUFACTURER

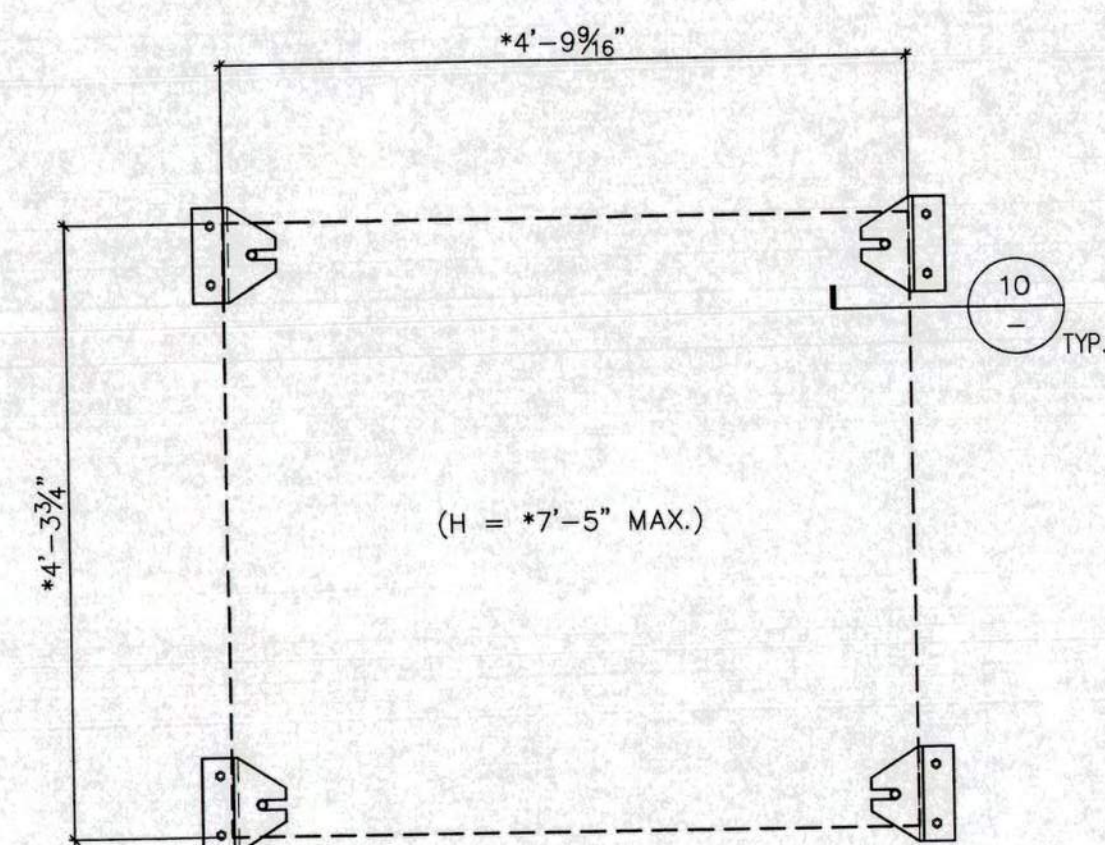


9 ANCHOR LAYOUT
UNWIND/REWIND

NOTE: CONTRACTOR SHALL VERIFY ALL DIMENSIONS IN FIELD. NO DEVIATION FROM DETAIL IS PERMITTED W/O WRITTEN APPROVAL FROM SEOR.

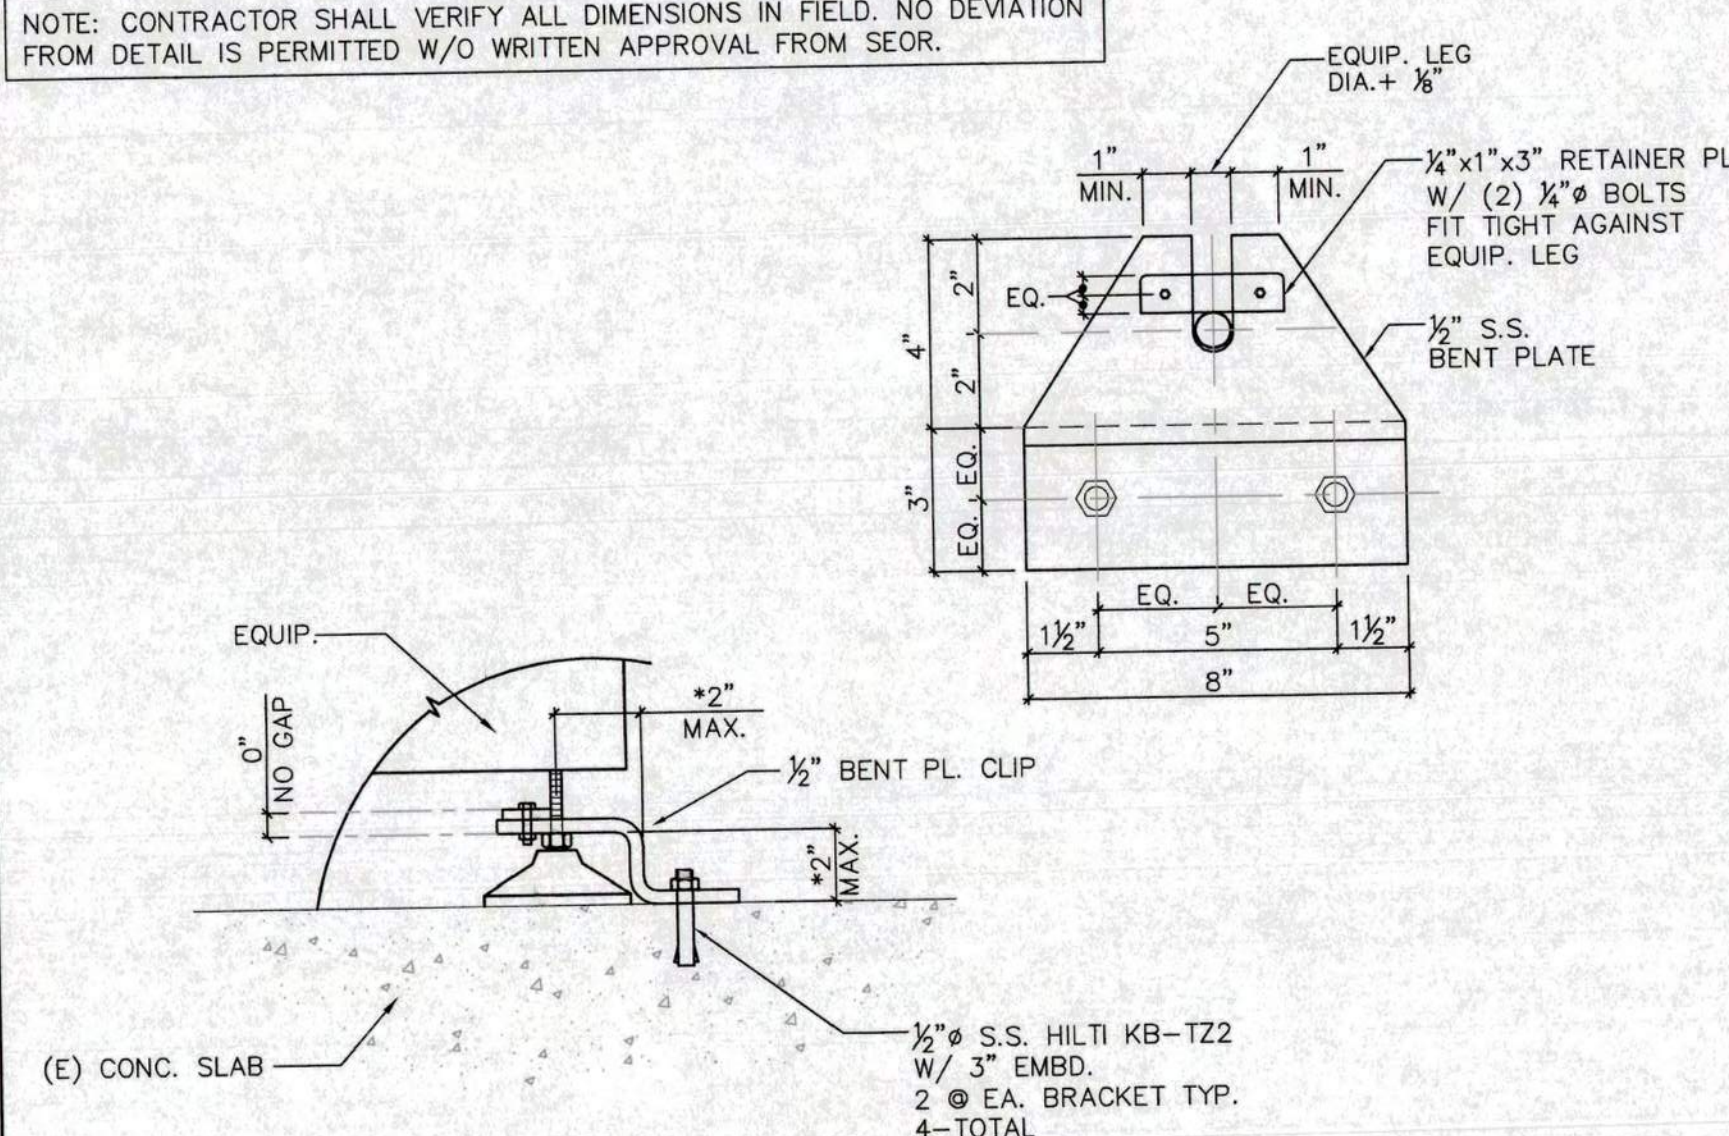


10 ANCHOR DETAILS
UNWIND/REWIND

* CONTRACTOR TO VERIFY DIMENSIONS WITH MANUFACTURER

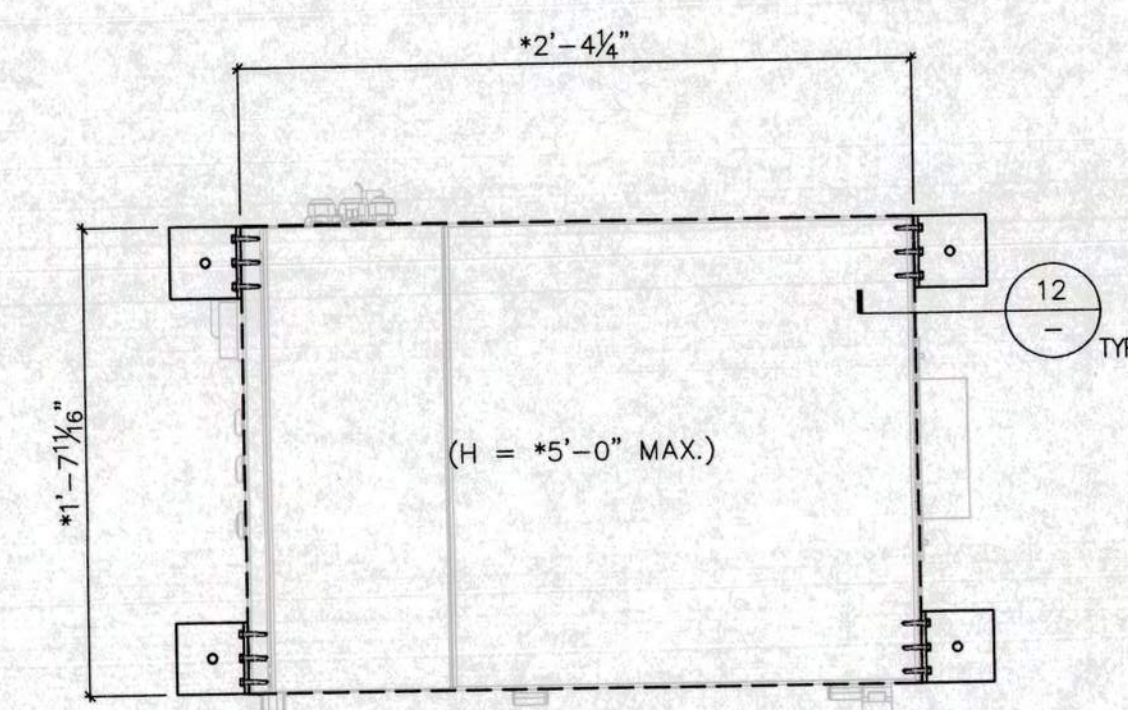

11 ANCHOR LAYOUT
ESUC UNIT

NOTE: CONTRACTOR SHALL VERIFY ALL DIMENSIONS IN FIELD. NO DEVIATION FROM DETAIL IS PERMITTED W/O WRITTEN APPROVAL FROM SEOR.

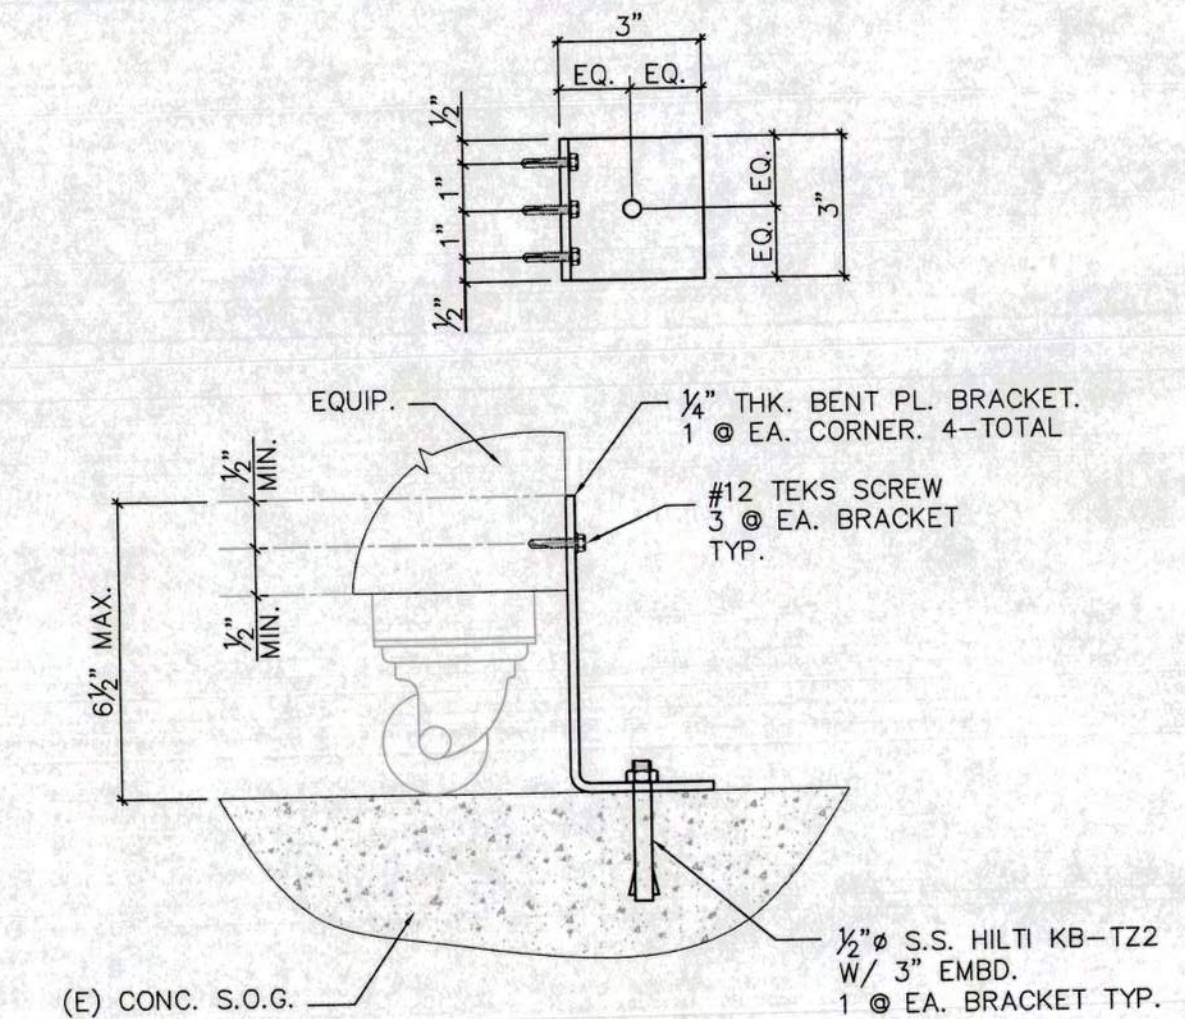

12 ANCHOR DETAILS
ESUC UNIT

CITY OF SAN JOSE
BUILDING DIVISION
B.P. #
DATE

BLDG.2 PHASE 2.53 - INDUSTRIAL TOOL
INSTALLATIONS

DETAILS

Scale: AS NOTED
Project No: 26023
DWG. NO.

SDT47.0

Pacific Crest
ENGINEERING INC.
444 Airport Blvd., Suite 106
Watsonville, CA 95076
Ph: (831) 763-6191
Fax: (831) 722-9158

QuantumScape
BATTERY, Inc.
1710 AUTOMATION PARKWAY
SAN JOSE
CALIFORNIA 95131

APPLIED ENGINEERING
CONSULTING STRUCTURAL ENGINEERS
991 MONTAGUE EXPWY. SUITE 207
MILPITAS, CA 95035
TEL: (408) 283-5800 FAX: (408) 283-5815
EMAIL: info@appliedee.com



Rev Date Issued for Permit